


COMBINED UNIT 2804/05 MECHANICAL FLOOR PLAN
SCALE: 1/4"=1'-0"

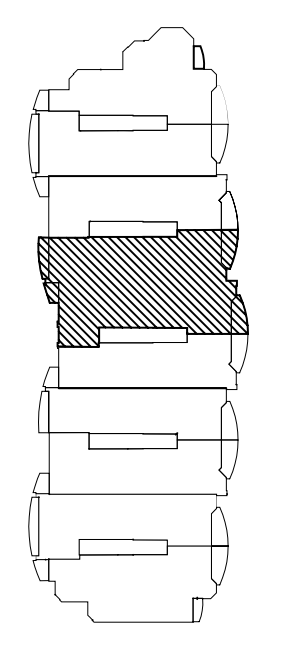

KEY PLAN
N.T.S.

pgi
pgigroup
MEP CONSULTING ENGINEERS
1201 Brickell Ave., Suite 600A Miami, FL 33131
Tel: 305-441-9330
www.pgiconsulting.com

<p>NEW CONDOMINIUM FOR: THE HAMPTONS AVENTURA, FLORIDA UNIT # 2804/05 MECHANICAL FLOOR PLAN</p>	<p>DATE: 07/23/05 DRAWN BY: A.G. PROJECT: 9910</p>
--	--

COHEN · FREEDMAN · ENCINOSA & ASSOC.
Architects, PA
8085 N.W. 155th Street Miami Lakes, Florida 33016 305-826-3999